



Schematic Drawing  
 For Review  
 Not for Construction

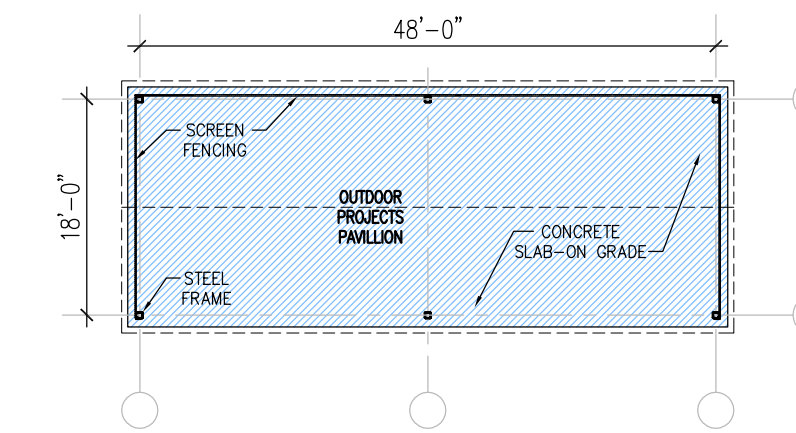



**Pavillion Plan**  
 SCALE: 1/8" = 1'-0"

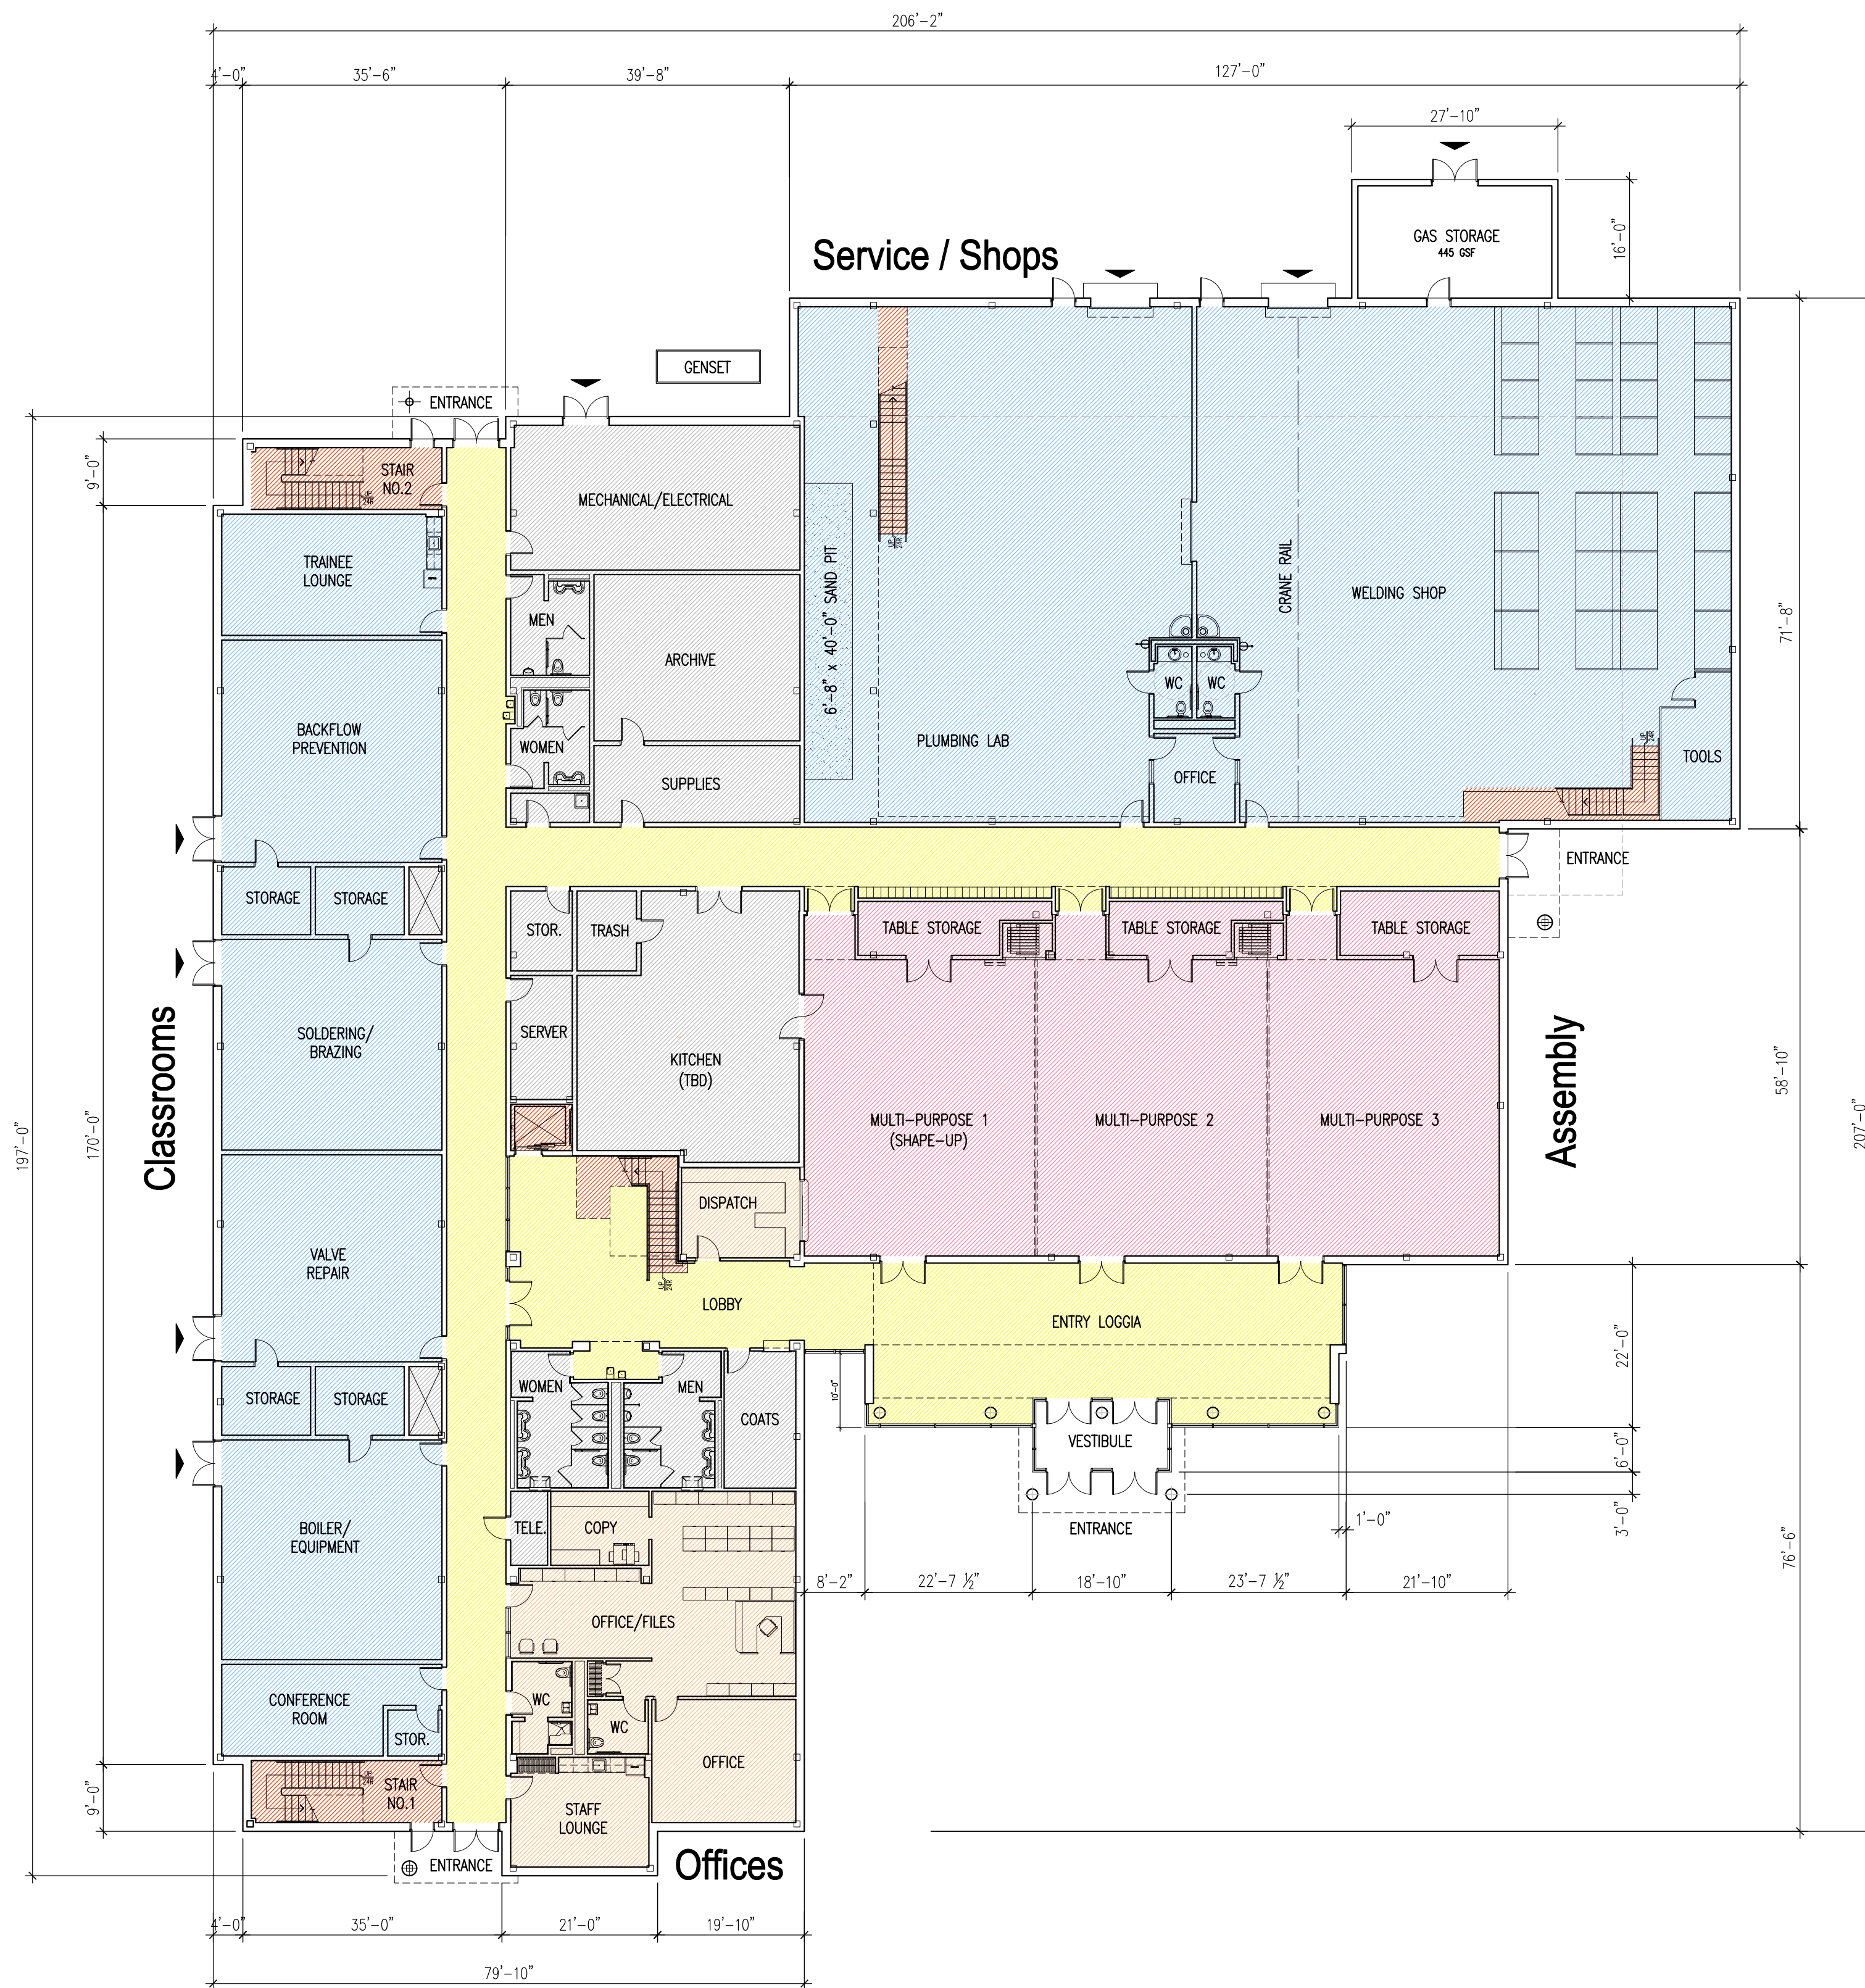

**First Floor Plan**  
 SCALE: 1/8" = 1'-0"



**Second Floor Plan**  
 SCALE: 1/8" = 1'-0"

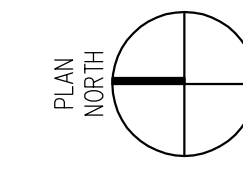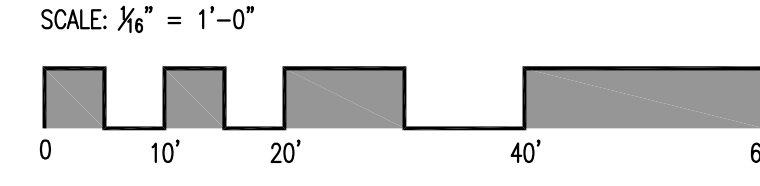


- ADMINISTRATION
- TRAINING
- ASSEMBLY
- COMMON/CORE
- CIRCULATION
- VERT. CIRCULATION

BUILDING DATA  
 FIRST FLOOR: 31,940 GSF  
 SECOND FLOOR: 18,434 GSF  
 TOTAL: 50,374 GSF  
 PAVILLION: 1,000 GSF

ISSUE	DATE	TITLE
01	01-28-2022	SITE PLAN SUBMISSION
02	03-31-2022	SIGNAGE: SEE DWG. A-2

PROJECT NO: 20-30100  
 PROJECT: Headquarters and Training Facility  
**United Association of Plumbers and Pipefitters Local Union #9 AFL-CIO**  
 East Windsor Township Mercer County New Jersey

**FIRST & SECOND FLOOR PLANS: SCHEMATIC STUDY 5**

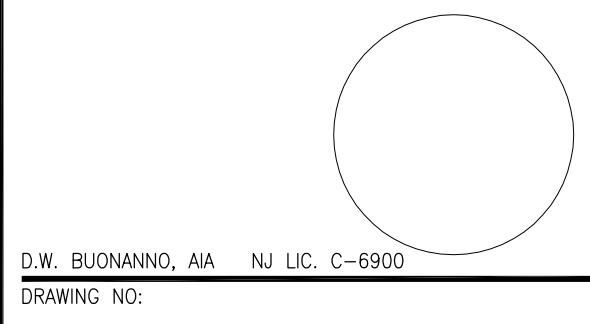

D.W. BUONNANO, AIA NJ LIC. C-6900  
 DRAWING NO: