


A-7


Schematic Drawing For Review Not for Construction

SEE DRAWING A-2 FOR ADDITIONAL DETAILS AND DIMENSIONAL INFORMATION FOR BUILDING MOUNTED SIGNAGE.

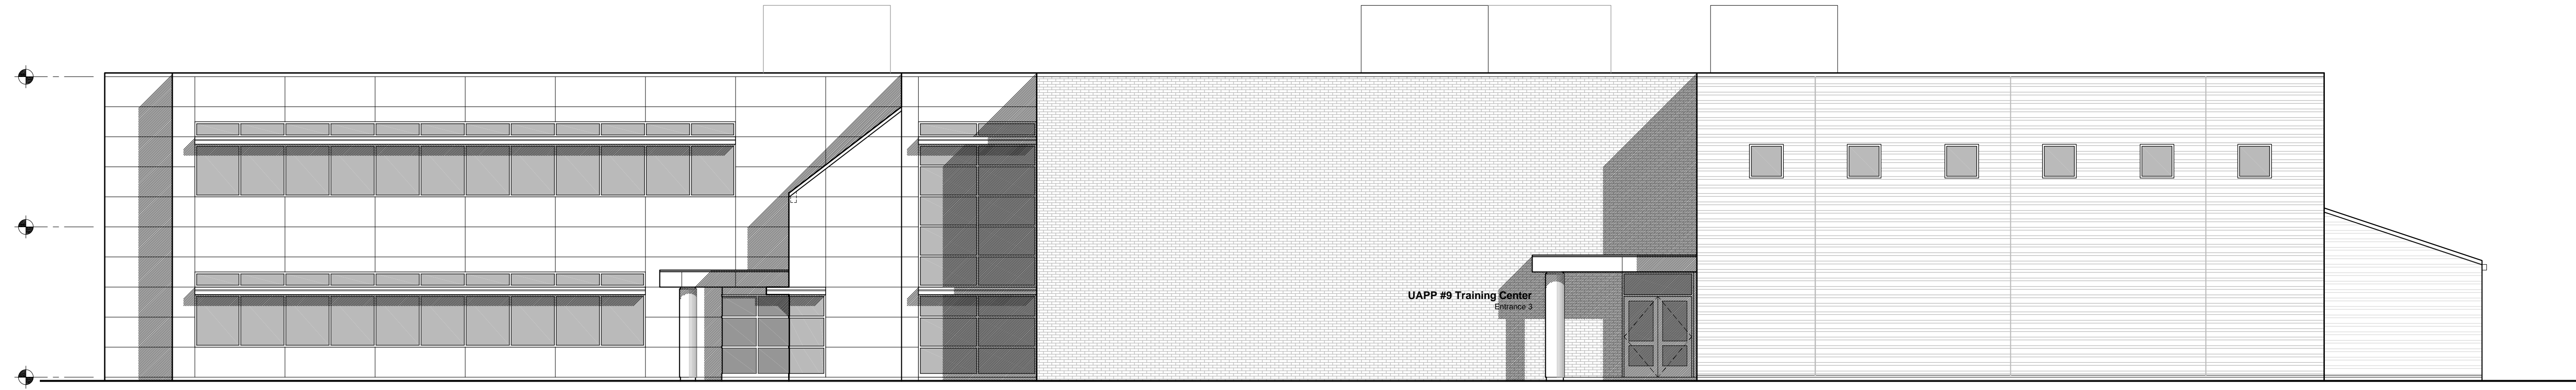

SOUTH ELEVATION

SCALE: 1/8" = 1'-0"

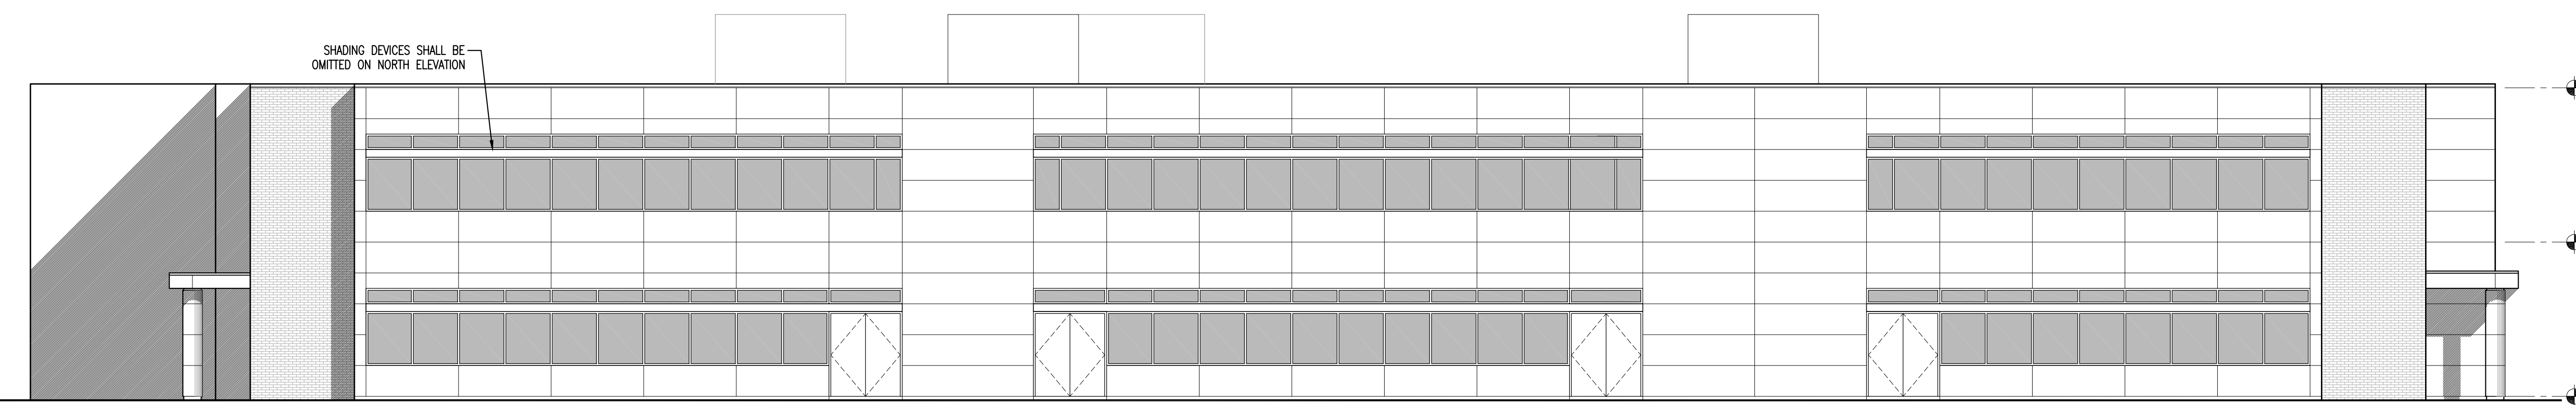

NORTH ELEVATION

SCALE: 1/8" = 1'-0"



ISSUE:	DATE:	TITLE:
01	01-28-2022	SITE PLAN SUBMISSION
02	03-31-2022	SIGNAGE: SEE DWG. A-2

PROJECT NO.: 20-30100
 PROJECT: Headquarters and Training Facility
 United Association of Plumbers and Pipefitters Local Union #9 AFL-CIO
 East Windsor Township Mercer County New Jersey

ELEVATIONS: SCHEMATIC STUDY 6

D.W. BUONANNI, AIA NJ LIC. C-6900 DRAWING NO.:

A-4